


H O O V E R
& F U R R

ARCHITECTS
A 3D/International Company



ESMOND & CLIFFORD
MEP ENGINEERING

1900 West Loop South
Suite 500
Houston, Texas 77027-3292
Tel 713/871-7400
Fax 713/871-7174

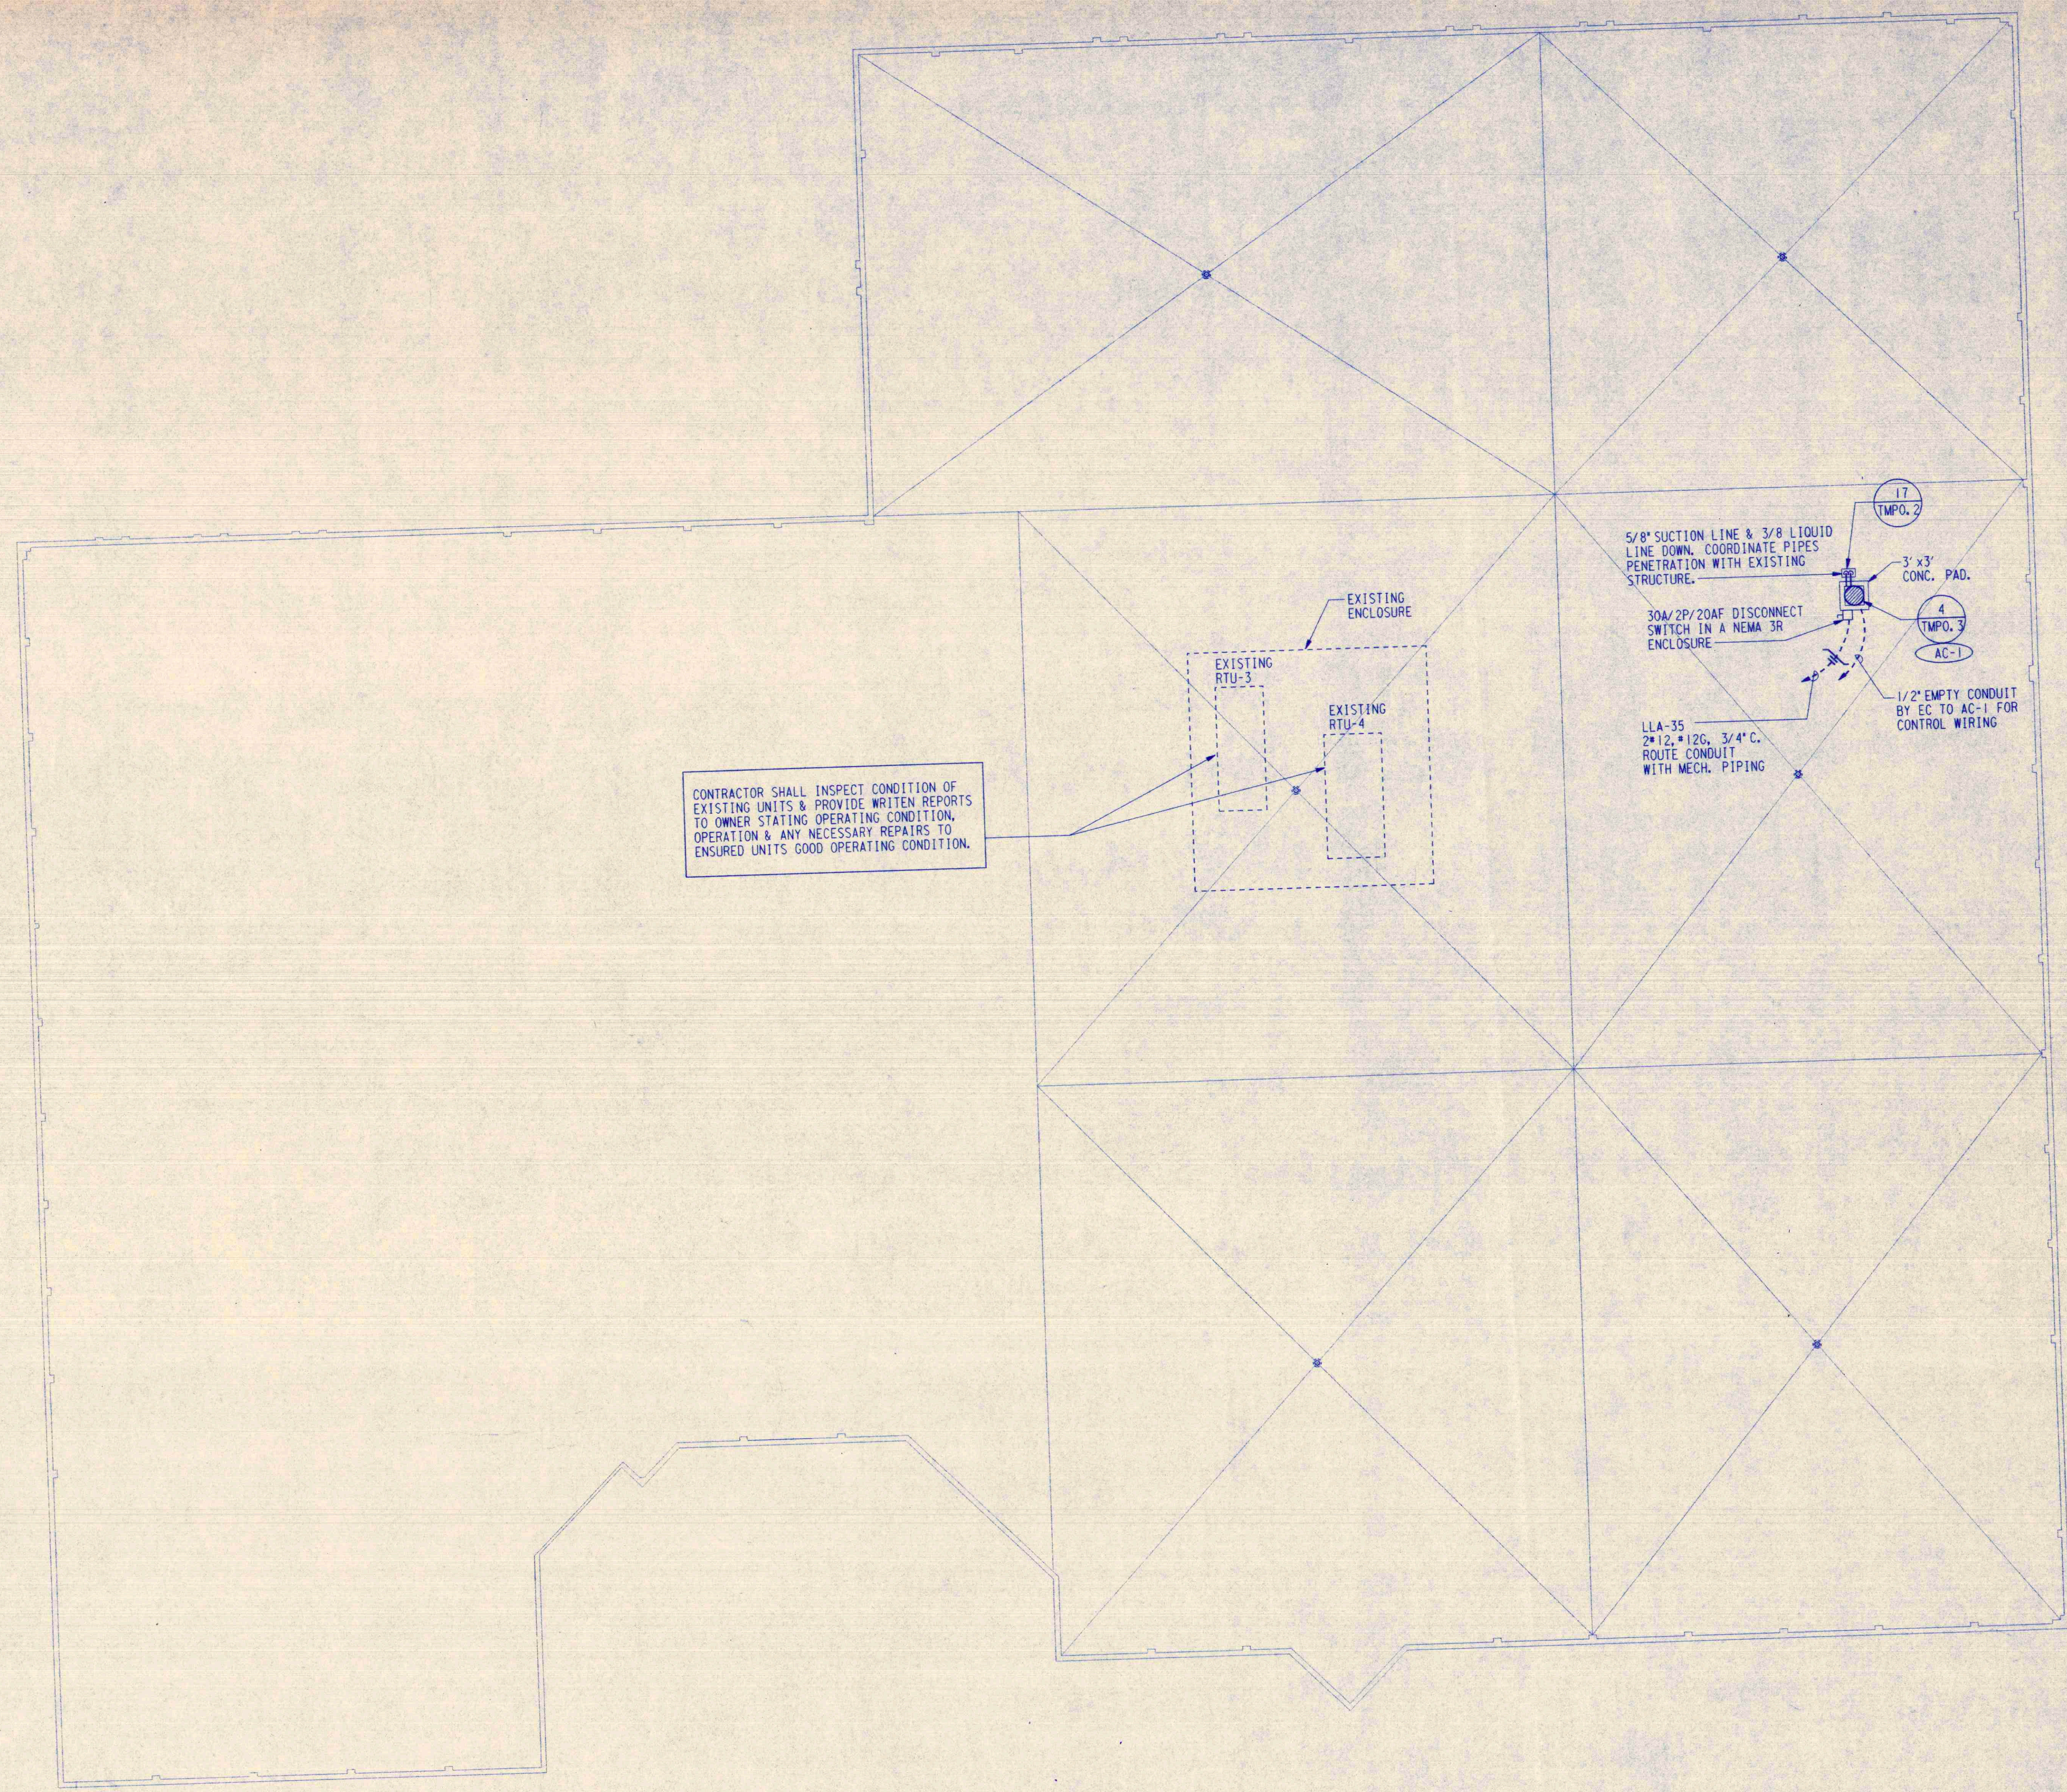

CONTRACTOR SHALL INSPECT CONDITION OF EXISTING UNITS & PROVIDE WRITTEN REPORTS TO OWNER STATING OPERATING CONDITION, OPERATION & ANY NECESSARY REPAIRS TO ENSURED UNITS GOOD OPERATING CONDITION.

01	05-24-93	ISSUE FOR CONSTRUCTION	
	04-13-93	ISSUE FOR PRICING	
No.	GGD	Date	Description

Revisions

TEXACO CHEMICAL COMPANY

**INTERIOR CONSTRUCTION
AND FINISH-OUT**

**TRIANGLE PLAZA BUILDING
HWY 365
PORT ARTHUR, TEXAS**

**MECHANICAL/ELECTRICAL
ROOF PLAN**

Sheet Date
Sheet Number
Project No. M9913

TME2.1

Project Engineer DAB
Checked by WCC