

CANCER TREATMENT CENTER

Baptist Hospitals of Southeast Texas

3180 COLLEGE STREET

CONSULTANT:


 PRICE CONSULTING, INC.
 PRICE CONSULTING, INC.
 211 HIGHWAY 890, SUITE 220
 HOUSTON, TEXAS 77073
 PHONE: (281) 259-1244
 FAX: (281) 259-2742
 TX P.E. # F-3814

| | |
|---------------------|-------------------------------------|
| ISSUED FOR | <input checked="" type="checkbox"/> |
| SCHEMATIC DESIGN | |
| DATE: 6/21/23 | |
| DESIGN DEVELOPMENT | <input type="checkbox"/> |
| DATE: | |
| BIDS & CONSTRUCTION | <input type="checkbox"/> |
| DATE: | |
| REVISION: | |
| DATE: | |
| REVISION: | |
| DATE: | |
| REVISION: | |
| DATE: | |


DRAWINGS SHEET TITLE
ROOF PLAN

SHEET NUMBER
R2.00

22042
PROJECT NUMBER

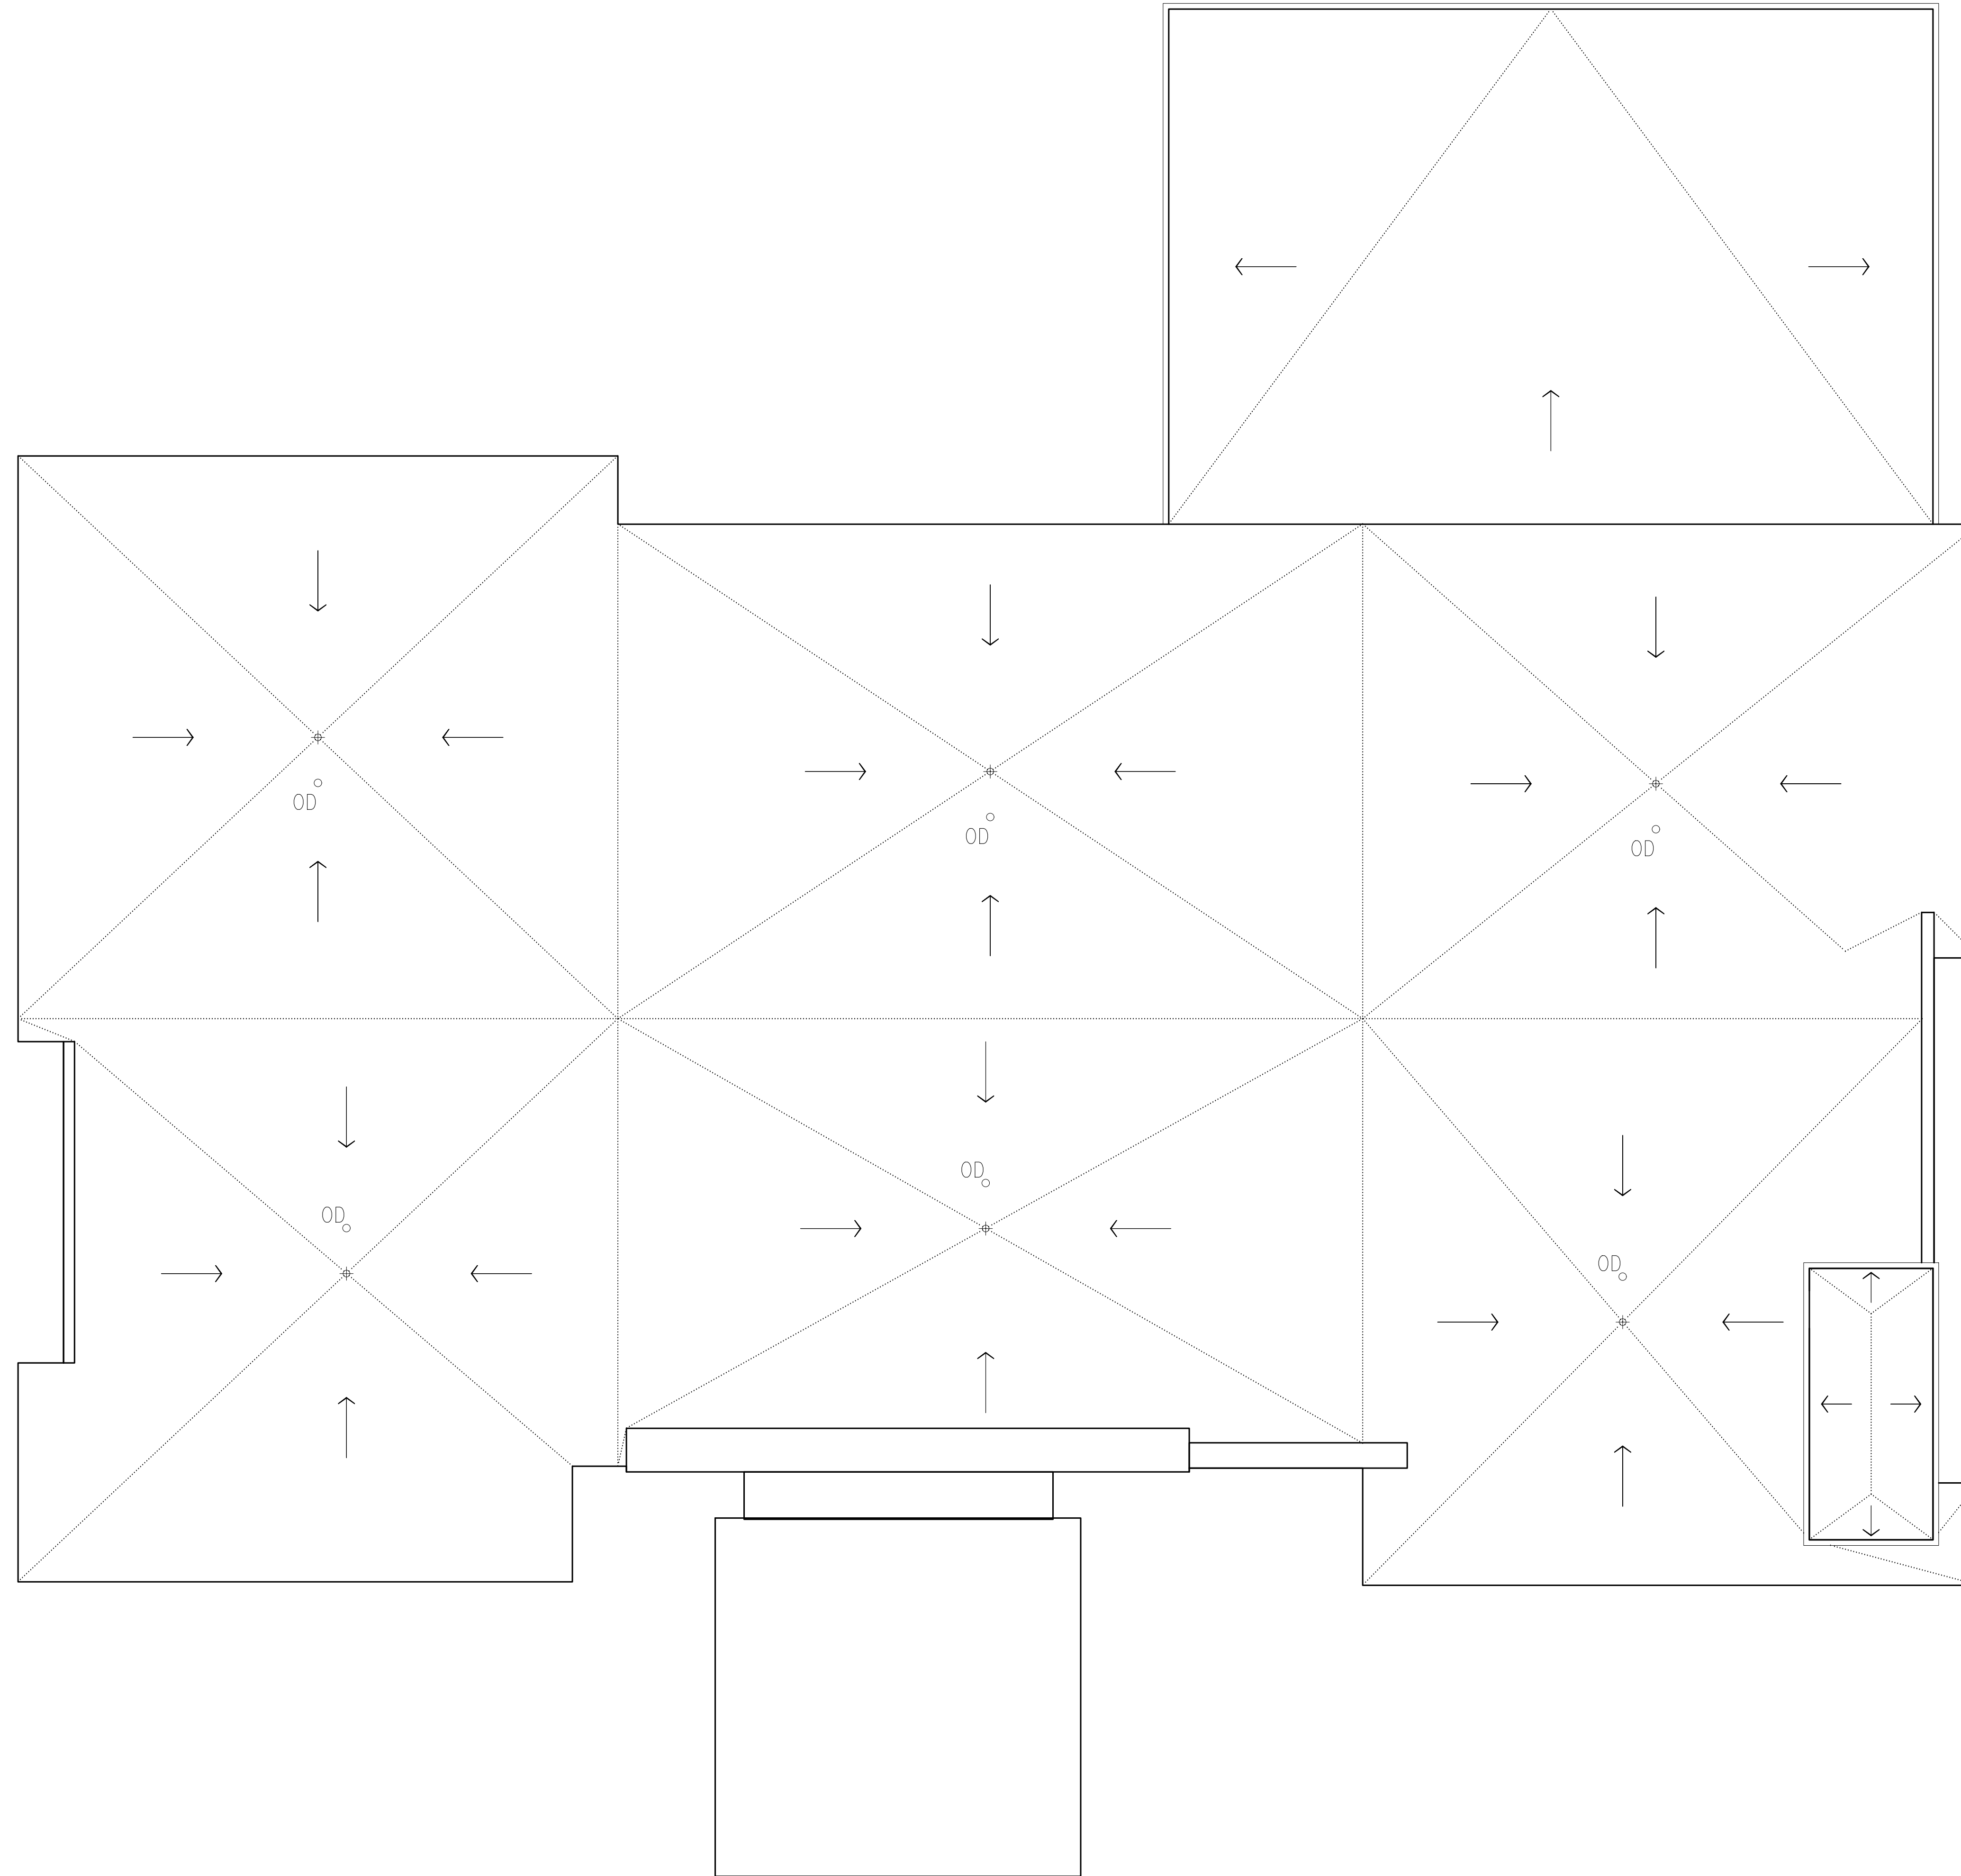

ROOF PLAN:
 CANCER TREATMENT CENTER
 SCALE: 1/8"=1'-0" (30"x42")

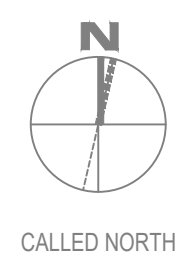

CALLED NORTH